


THIS DWG. IS SOLE PROPERTY OF NEOMETRIX ENGINEERING PVT. LTD.
UNAUTHORISED USE OF THIS DWG. OR MAKING PRODUCT AS PER THIS DWG.
WITHOUT OUR PERMISSION OR ANY OTHER MISUSE IS NOT PERMITTED.

SYSTEM DESIGN DATA
TEST FLUID: JET A-1
MAXIMUM PRESSURE: 10 BAR
MAXIMUM FLOW: 500 LPM
MAX OPERATING TEMPERATURE: 45 deg C

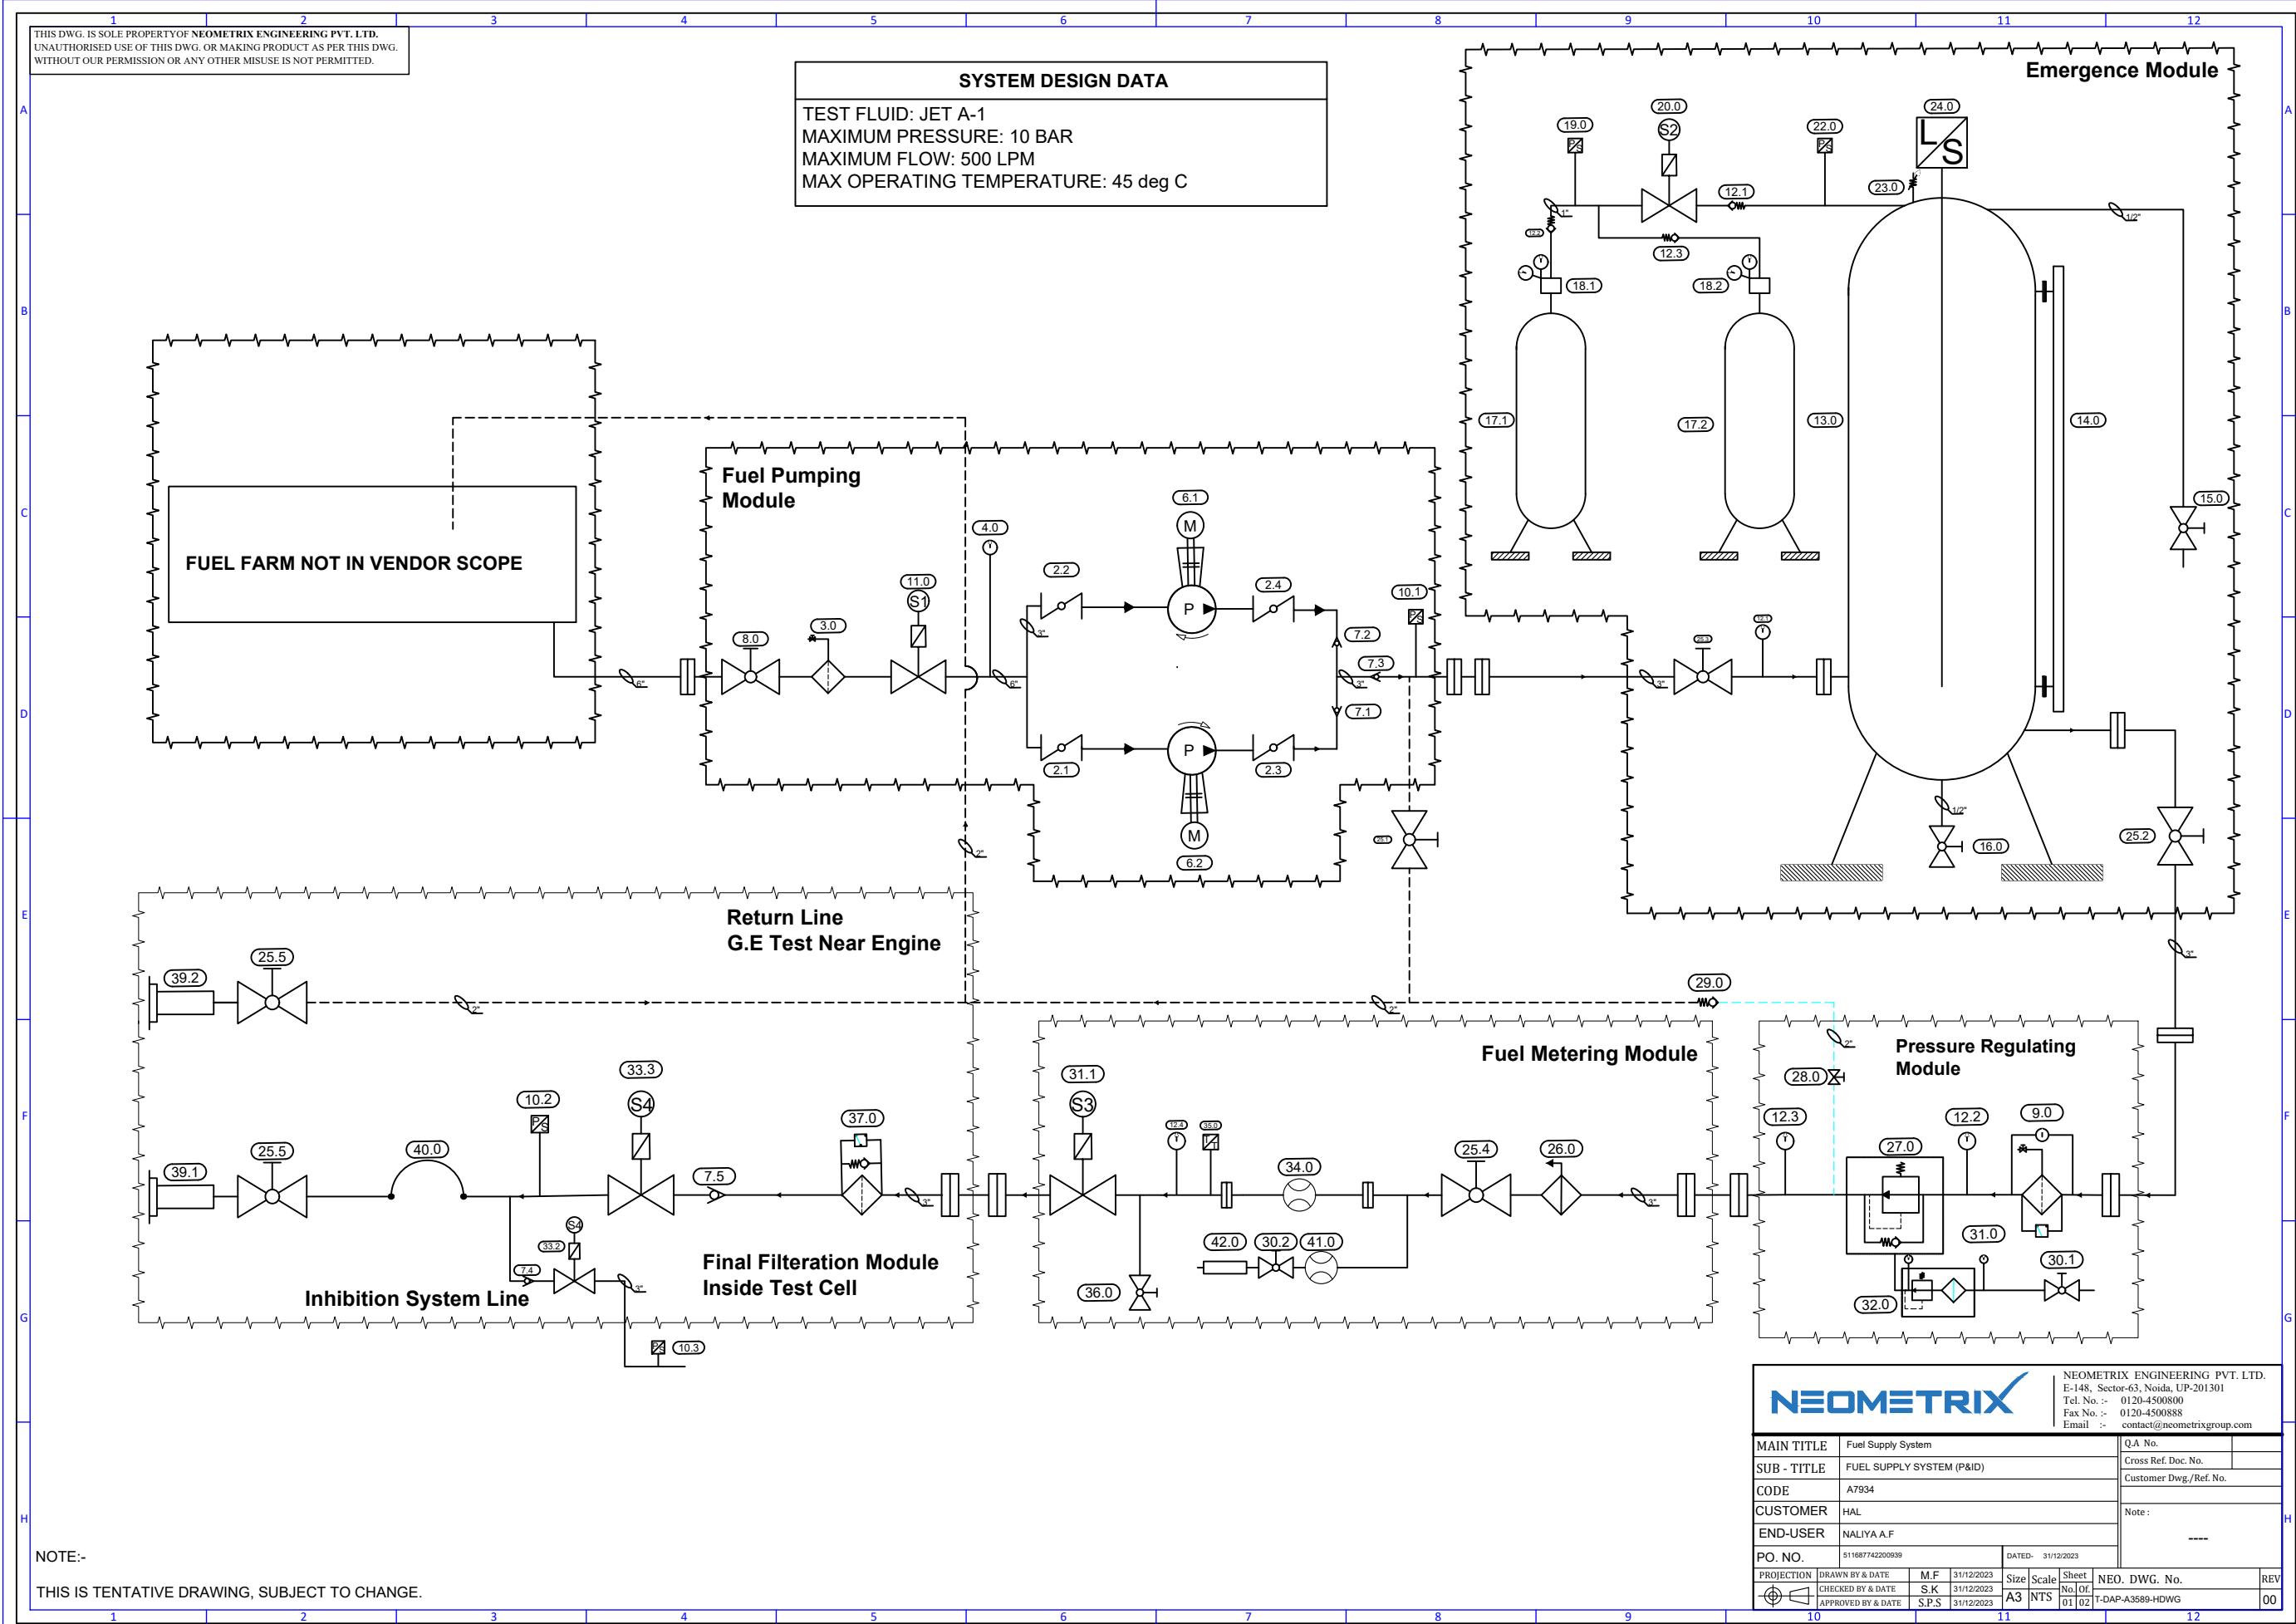

NOTE:-
THIS IS TENTATIVE DRAWING, SUBJECT TO CHANGE.

NEOMETRIX		NEOMETRIX ENGINEERING PVT. LTD. E-148, Sector-63, Noida, UP-201301 Tel. No. :- 0120-4500800 Fax No. :- 0120-4500888 Email :- contact@neometrixgroup.com	
MAIN TITLE	Fuel Supply System	QA No.	
SUB - TITLE	FUEL SUPPLY SYSTEM (P&ID)	Cross Ref. Doc. No.	
CODE	A7934	Customer Dwg./Ref. No.	
CUSTOMER	HAL	Note :	
END-USER	NALIYA A.F		
PO. NO.	51188742200939	DATED-	31/12/2023
PROJECTION	DRAWN BY & DATE	M.F	31/12/2023
	CHECKED BY & DATE	S.K	31/12/2023
	APPROVED BY & DATE	S.P.S	31/12/2023
	Size	Scale	Sheet
	A3	NTS	No. Of. 01
			02
	NEO. DWG. No.		REV
	T-DAP-A3589-HDWG		00